

NOT
FOR CONSTRUCTION
THESE PLANS HAVE NOT BEEN
APPROVED AND ARE SUBJECT
TO CHANGE.

A Landscape Development Plan for
Oyster Bay Townhomes
Gulf Shores, Alabama

No.	Date	Revisions / Submissions
01.10.22		PERMIT SUBMITTAL
01.28.22		PERMIT RESUBMITTAL
02.14.22		REVISED PER CITY COMMENT


© Copyright 2021 WAS Design Inc. These documents and their contents are the property of WAS Design. Any reproductions, revisions, modifications or use of these documents without the express written consent of WAS Design is prohibited by law.

BH	Registration
Drawn	
DM	
Project Manager	
LCW	
Principal	
214016-014	
Project No.	
12.23.21	
Date	

Sheet Title

**SITE LIGHTING PLAN
ENLARGEMENT**

Sheet No.
LE201

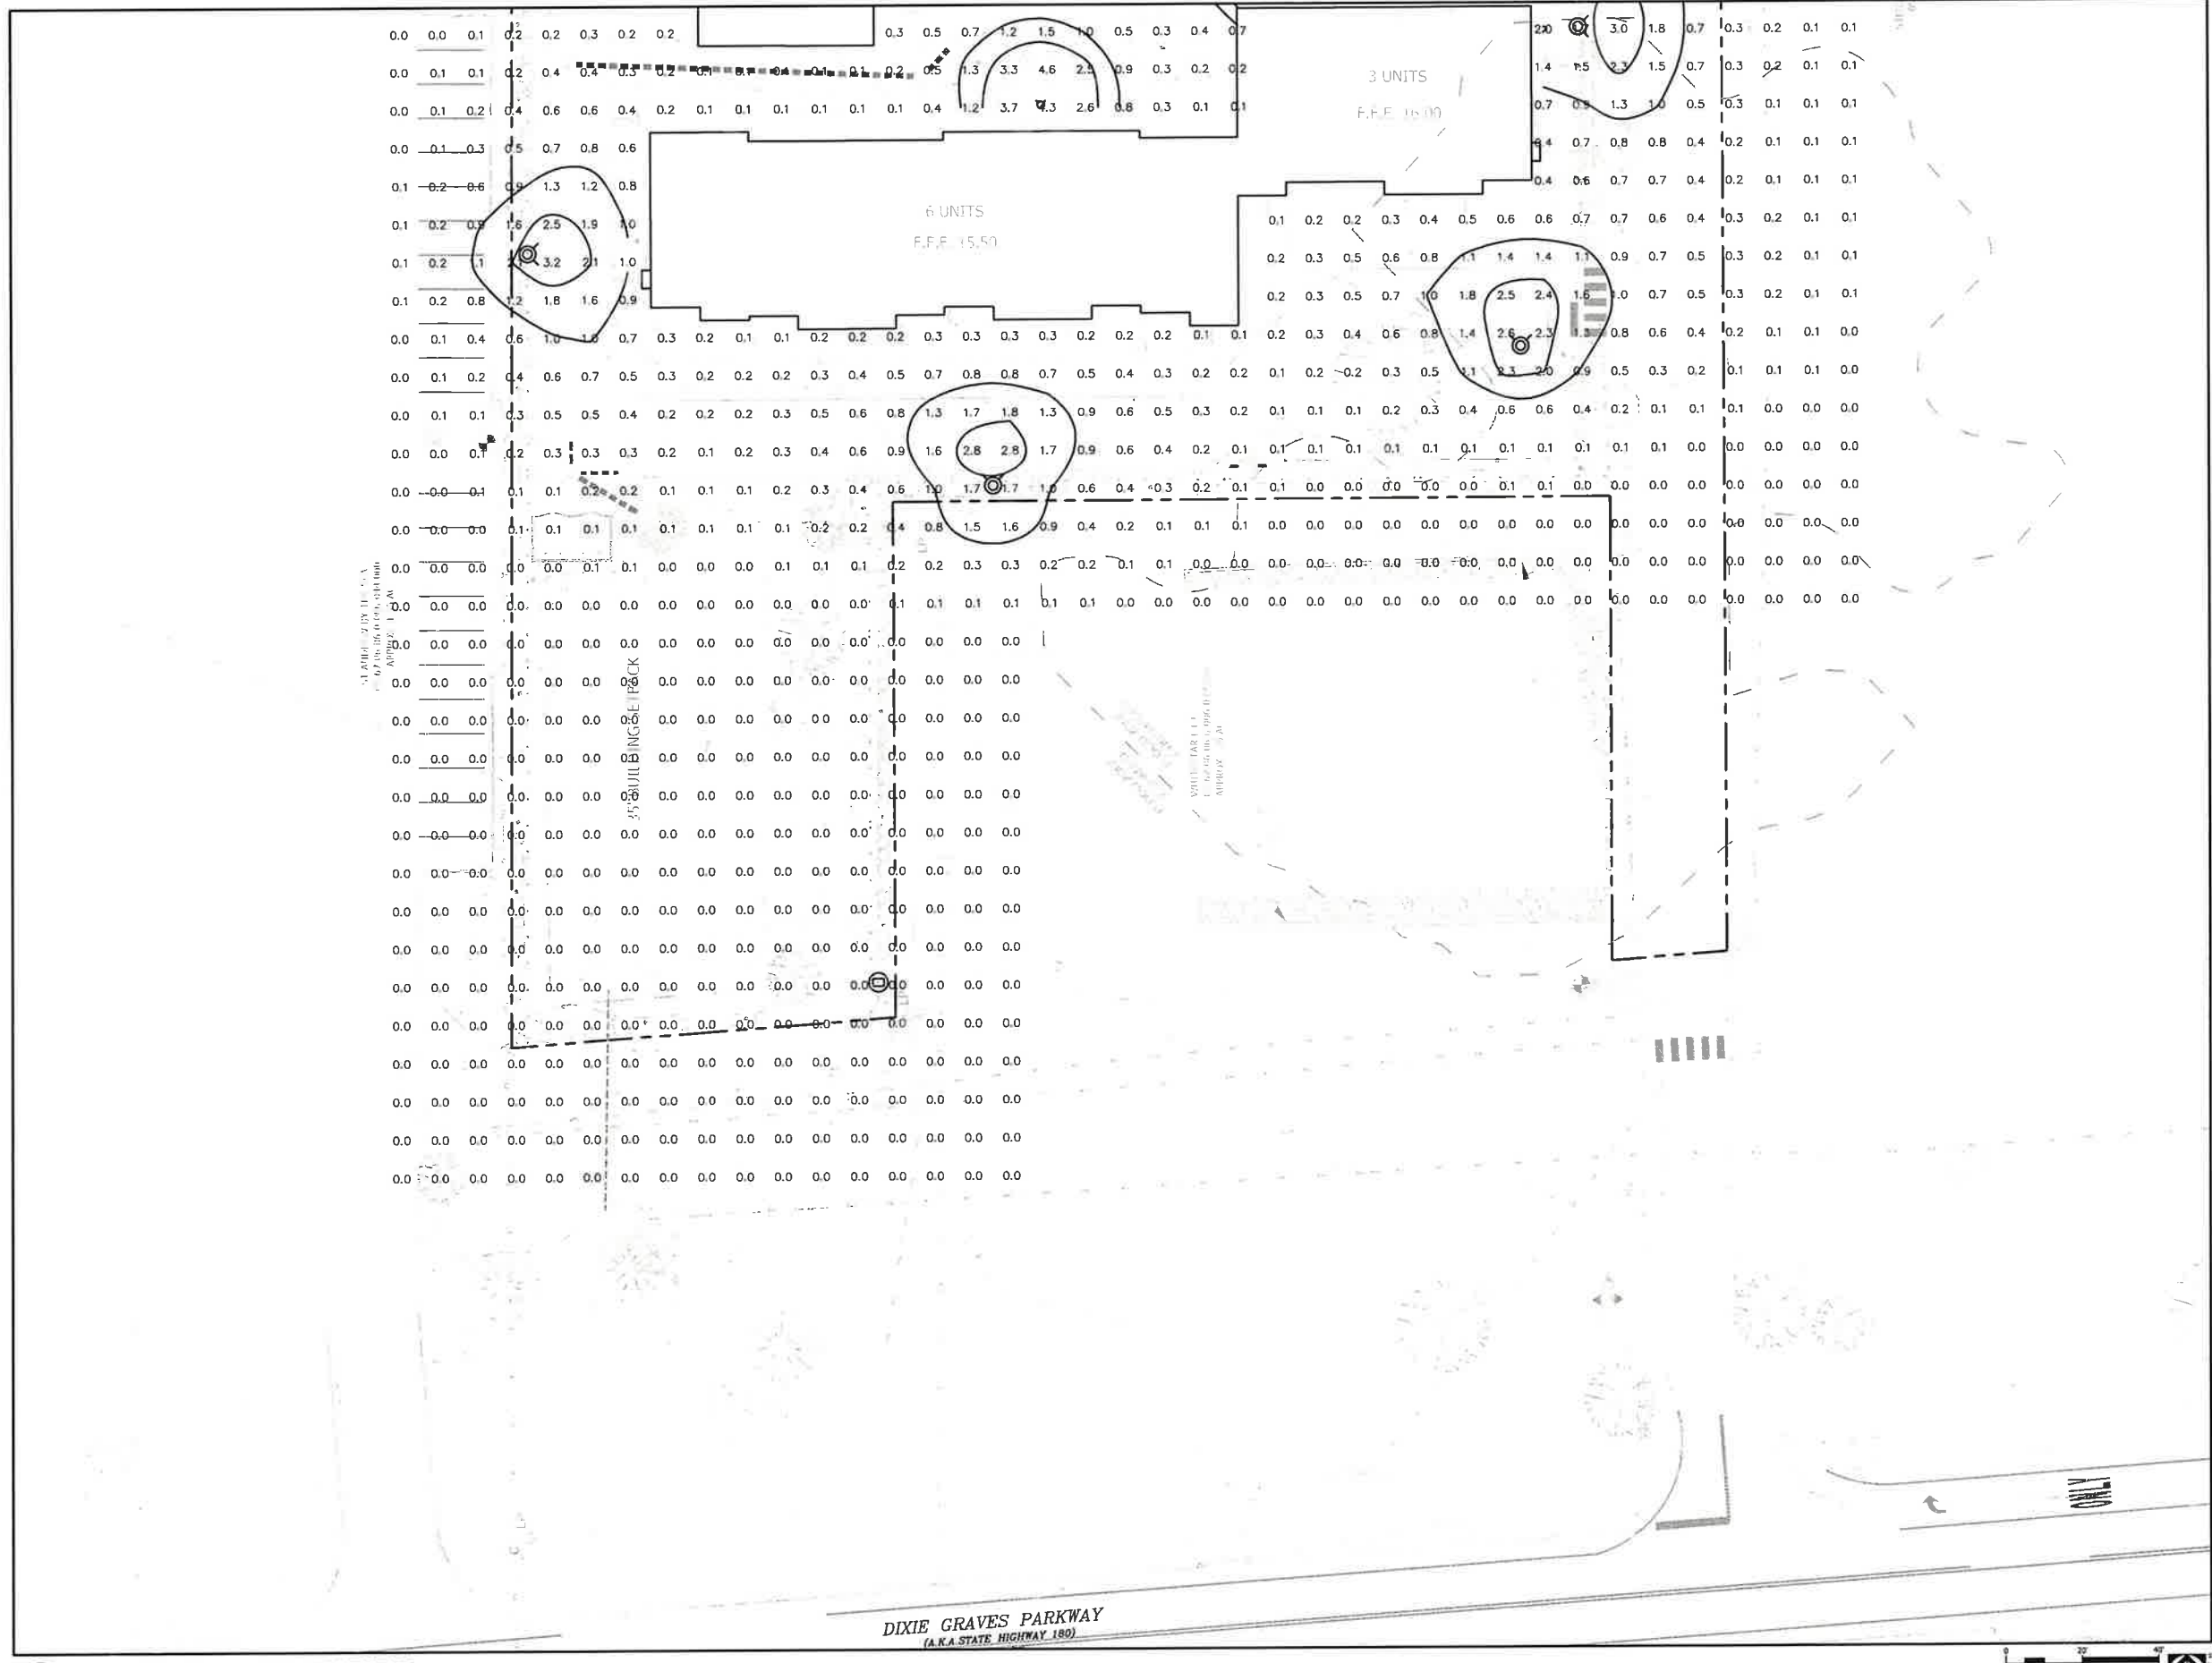

1 SITE LIGHTING PLAN ENLARGEMENT
Scale: 1" = 20'

DIXIE GRAVES PARKWAY
(A.K.A. STATE HIGHWAY 180)

NOT
FOR CONSTRUCTION
THESE PLANS HAVE NOT BEEN
APPROVED AND ARE SUBJECT
TO CHANGE.

A Landscape Development Plan for
Oyster Bay Townhomes
Gulf Shores, Alabama

Revisions		
No.	Date	Revisions / Submissions
01.10.22		PERMIT SUBMITTAL
01.28.22		PERMIT RESUBMITTAL
02.14.22		REVISED PER CITY COMMENT

© Copyright 2021 WAS Design Inc. These documents and their contents are the property of WAS Design. Any reproductions, revisions, modifications or use of these documents without the express written consent of WAS Design is prohibited by law.

BH Drawn	Registration
DM Project Manager	
LCW Principal	
214016-014 Project No.	
12.23.21 Date	

**SITE LIGHTING
DETAILS**

Sheet No.
LE500

LUSSO ARRAY M-PT Serenity Lens LED Specifications



Project Name: _____
Catalog Number: _____
Type: _____

Our temporary design meets the new generation of LED green technology in the lighting industry with the **Lusso Array**. The Lusso Array series provides over 70% per watt energy savings over traditional HID light fixtures and comes complete in a range of sizes to LED light output of 100-500 lumens for 1100 mounting systems. The Lusso Array is offered in a range of color temperatures.

The Lusso Array is fully tested for long life and an over 50,000 hour design life. Thermal capacity is tested system for proper heat dissipation.

The Lusso Array is built with cast aluminum.

The **Lusso Array** is the perfect complement to a luxury residential, business park or walkway project where temporary lighting is required.

Ordering Information

MODEL	OPTICS	LUMENS	KELVIN	VOLTAGE	MOUNTING	FINISH	SERENITY LENS	OPTIONS	OPTIONS
LSO-M	T3L	5L	3K	UNV	PTS	BK	LDL	PCR-120	WSC-8
	T1 Type 1	5L	3000K	120-277V	PTS Post Top Single Arm	BK Black	LDL LED Lens	PCR-206	Wagon Wheel Mounting
	T2 Type 2	8L	4K	8	PTD Post Top Double Arm	SBK Smooth Black	HDL High Definition Lens	PCR-240	Mounting Height
	T3L Type 3 Long	14L	4000K	8	PTD Post Top Double Arm	BZ Bronze	GP Granite	PCR-277	Mounting Height
	T4L Type 4 Long	17L	5000K	480V	PTD Post Top Double Arm	GY Grey	SPINPER Spinper Mounting	PCR-347	Mounting Height
	T5L Type 5 Long Square				PTD Post Top Double Arm	WH White	SWH Smooth White	PCR-480	Mounting Height
					PTD Post Top Double Arm	FG Forest Green	VD Vintage Green	CC Custom Color	

LUSSO ARRAY M-PT LED Specifications



Project Name: _____
Catalog Number: _____
Type: _____

Our temporary design meets the new generation of LED green technology in the lighting industry with the **Lusso Array**. The Lusso Array series provides over 70% per watt energy savings over traditional HID light fixtures and comes complete in a range of sizes to LED light output of 100-500 lumens for 1100 mounting systems. The Lusso Array is offered in a range of color temperatures.

The Lusso Array is fully tested for long life and an over 50,000 hour design life. Thermal capacity is tested system for proper heat dissipation.

The Lusso Array is built with cast aluminum.

The **Lusso Array** is the perfect complement to a luxury residential, business park or walkway project where temporary lighting is required.

Ordering Information

MODEL	OPTICS	LUMENS	KELVIN	VOLTAGE	MOUNTING	FINISH	OPTIONS	OPTIONS
LSO-M	T3L	10L	3K	UNV	PTS	BK	PCR-120	WSC-8
	T1 Type 1	10L	3000K	120-277V	PTS Post Top Single Arm	BK Black	PCR-206	Wagon Wheel Mounting
	T2 Type 2	15L	4K	8	PTD Post Top Double Arm	SBK Smooth Black	PCR-240	Mounting Height
	T3 Type 3	20L	5K	480V	PTD Post Top Double Arm	BZ Bronze	PCR-277	Mounting Height
	T3L Type 3 Long	25L	5000K	480V	PTD Post Top Double Arm	GY Grey	PCR-347	Mounting Height
	T4 Type 4				PTD Post Top Double Arm	WH White	PCR-480	Mounting Height
	T4L Type 4 Long				PTD Post Top Double Arm	FG Forest Green	VD Vintage Green	CC Custom Color
	T5L Type 5 Long Square				PTD Post Top Double Arm			
	T5L Type 5 Short Round				PTD Post Top Double Arm			

LUSSO Bollard LED Specifications



Project Name: _____
Catalog Number: _____
Type: _____

The **Lusso Bollard LED Series** continues the sleek and temporary design needed for a park or plaza. Depending on the desired height, the bollard can be 18" or 24" tall. The bollard is offered in a range of color temperatures. The Lusso Bollard is offered in a range of color temperatures.

The Lusso Bollard is fully tested for long life and an over 50,000 hour design life. Thermal capacity is tested system for proper heat dissipation.

The Lusso Bollard is built with cast aluminum.

The **Lusso Bollard LED Series** is an exceptional choice for walkway lighting.

Ordering Information

MODEL	HEIGHT	OPTICS	SOURCE	CURRENT	KELVIN	VOLTAGE	MOUNTING	FINISH	OPTIONS
LSO-B	S41	T3	20LC	1	3K	UNV	AB	BK	PCR-120
	18" (Type 3)	T1 Type 1	20LC	1	3000K	120-277V	AB Anodized Black	BK Black	Buller Type Projector
	S41 (Type 4)	T2 Type 2		3	4K			SBK Smooth Black	PCR-206
		T3 Type 3		5	5K			BZ Bronze	Buller Type Projector
		T4 Type 4		7	5000K			GP Granite	PCR-240
		T5 Type 5						GY Grey	Buller Type Projector
		T5W Type 5 Wide						WH White	DIM 0-10V Dimmable Driver
								SWH Smooth White	LDL LED Lens
								FG Forest Green	HDL High Definition Lens
								VD Vintage Green	VD Vintage Green
								CC Custom Color	GFI GFI Protected GFI Protected